




15BBL-4V-BREWHOUSE-P&ID

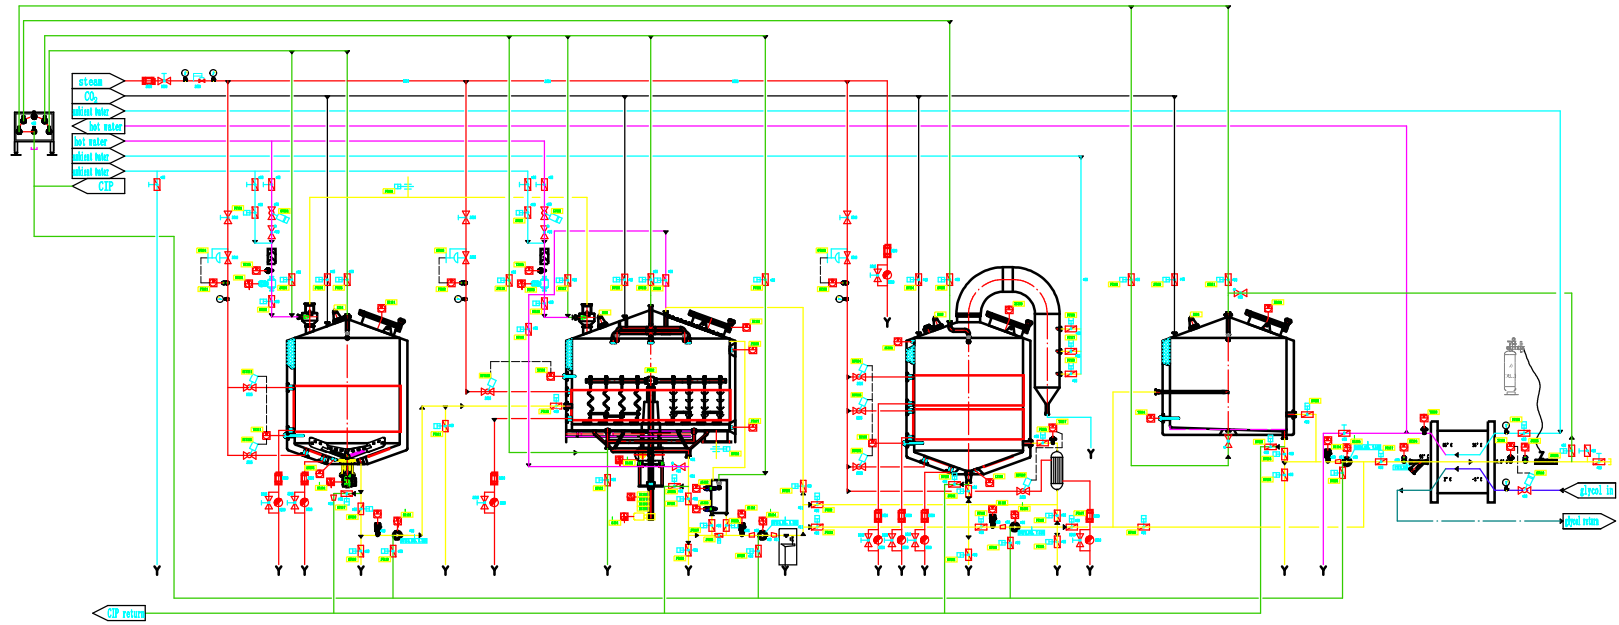


750L-2V-CIP SYSTEM-P&ID

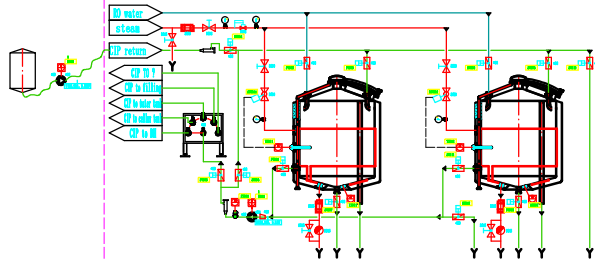

1000L-RO SYSTEM-P&ID

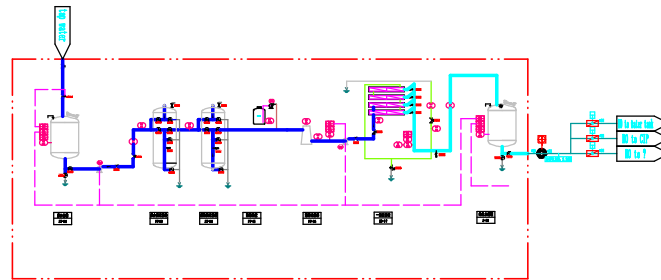

60BBL-2V-WATER SYSTEM-P&ID

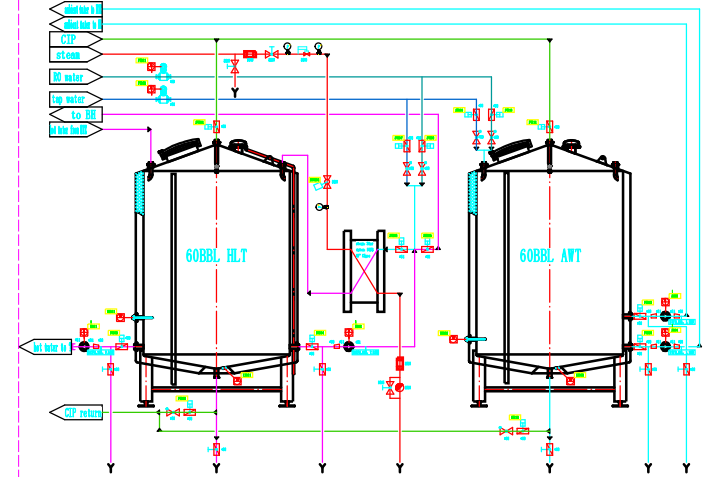

hot water
 ambient water
 steam
 Glycol return
 Glycol in
 RO water
 CIP
 Control
 RO Water
 RO Water

	Hand Ball Valve		Flow direction arrow		Pneumatic actuator		Pneumatic supply valve		Pneumatic supply valve
	Solenoil Valve		steam stop valve		VFD Control		Electromagnetic flowmeter		Y-Flow filter
	Hand Isolation Valve		steam pressure gauge		Temp Control		Level Control		Trap
	Sample Valve		wort aeration		Flow Control		PIVY		Pneumatic logic Sol Valve
	wort pump		traps		Temp Display		Check valve		

Project No.	
Drawing No.	
Version No.	V2.1
Author/Engineer	
Designer	Jason Wang
Draft man	
Proofreading	
Reviewer	

15BBL-4V-P&ID

Turnkey BREWERY

YI-04-1106A17

Drawing Mark	Quantity	Weight	Scale
Total	Page	page	1:50

YoLong YOLONG INDUSTRIAL CO., LTD.